




ADJUST DIRECTION OF NORTH ARROW AS NEEDED

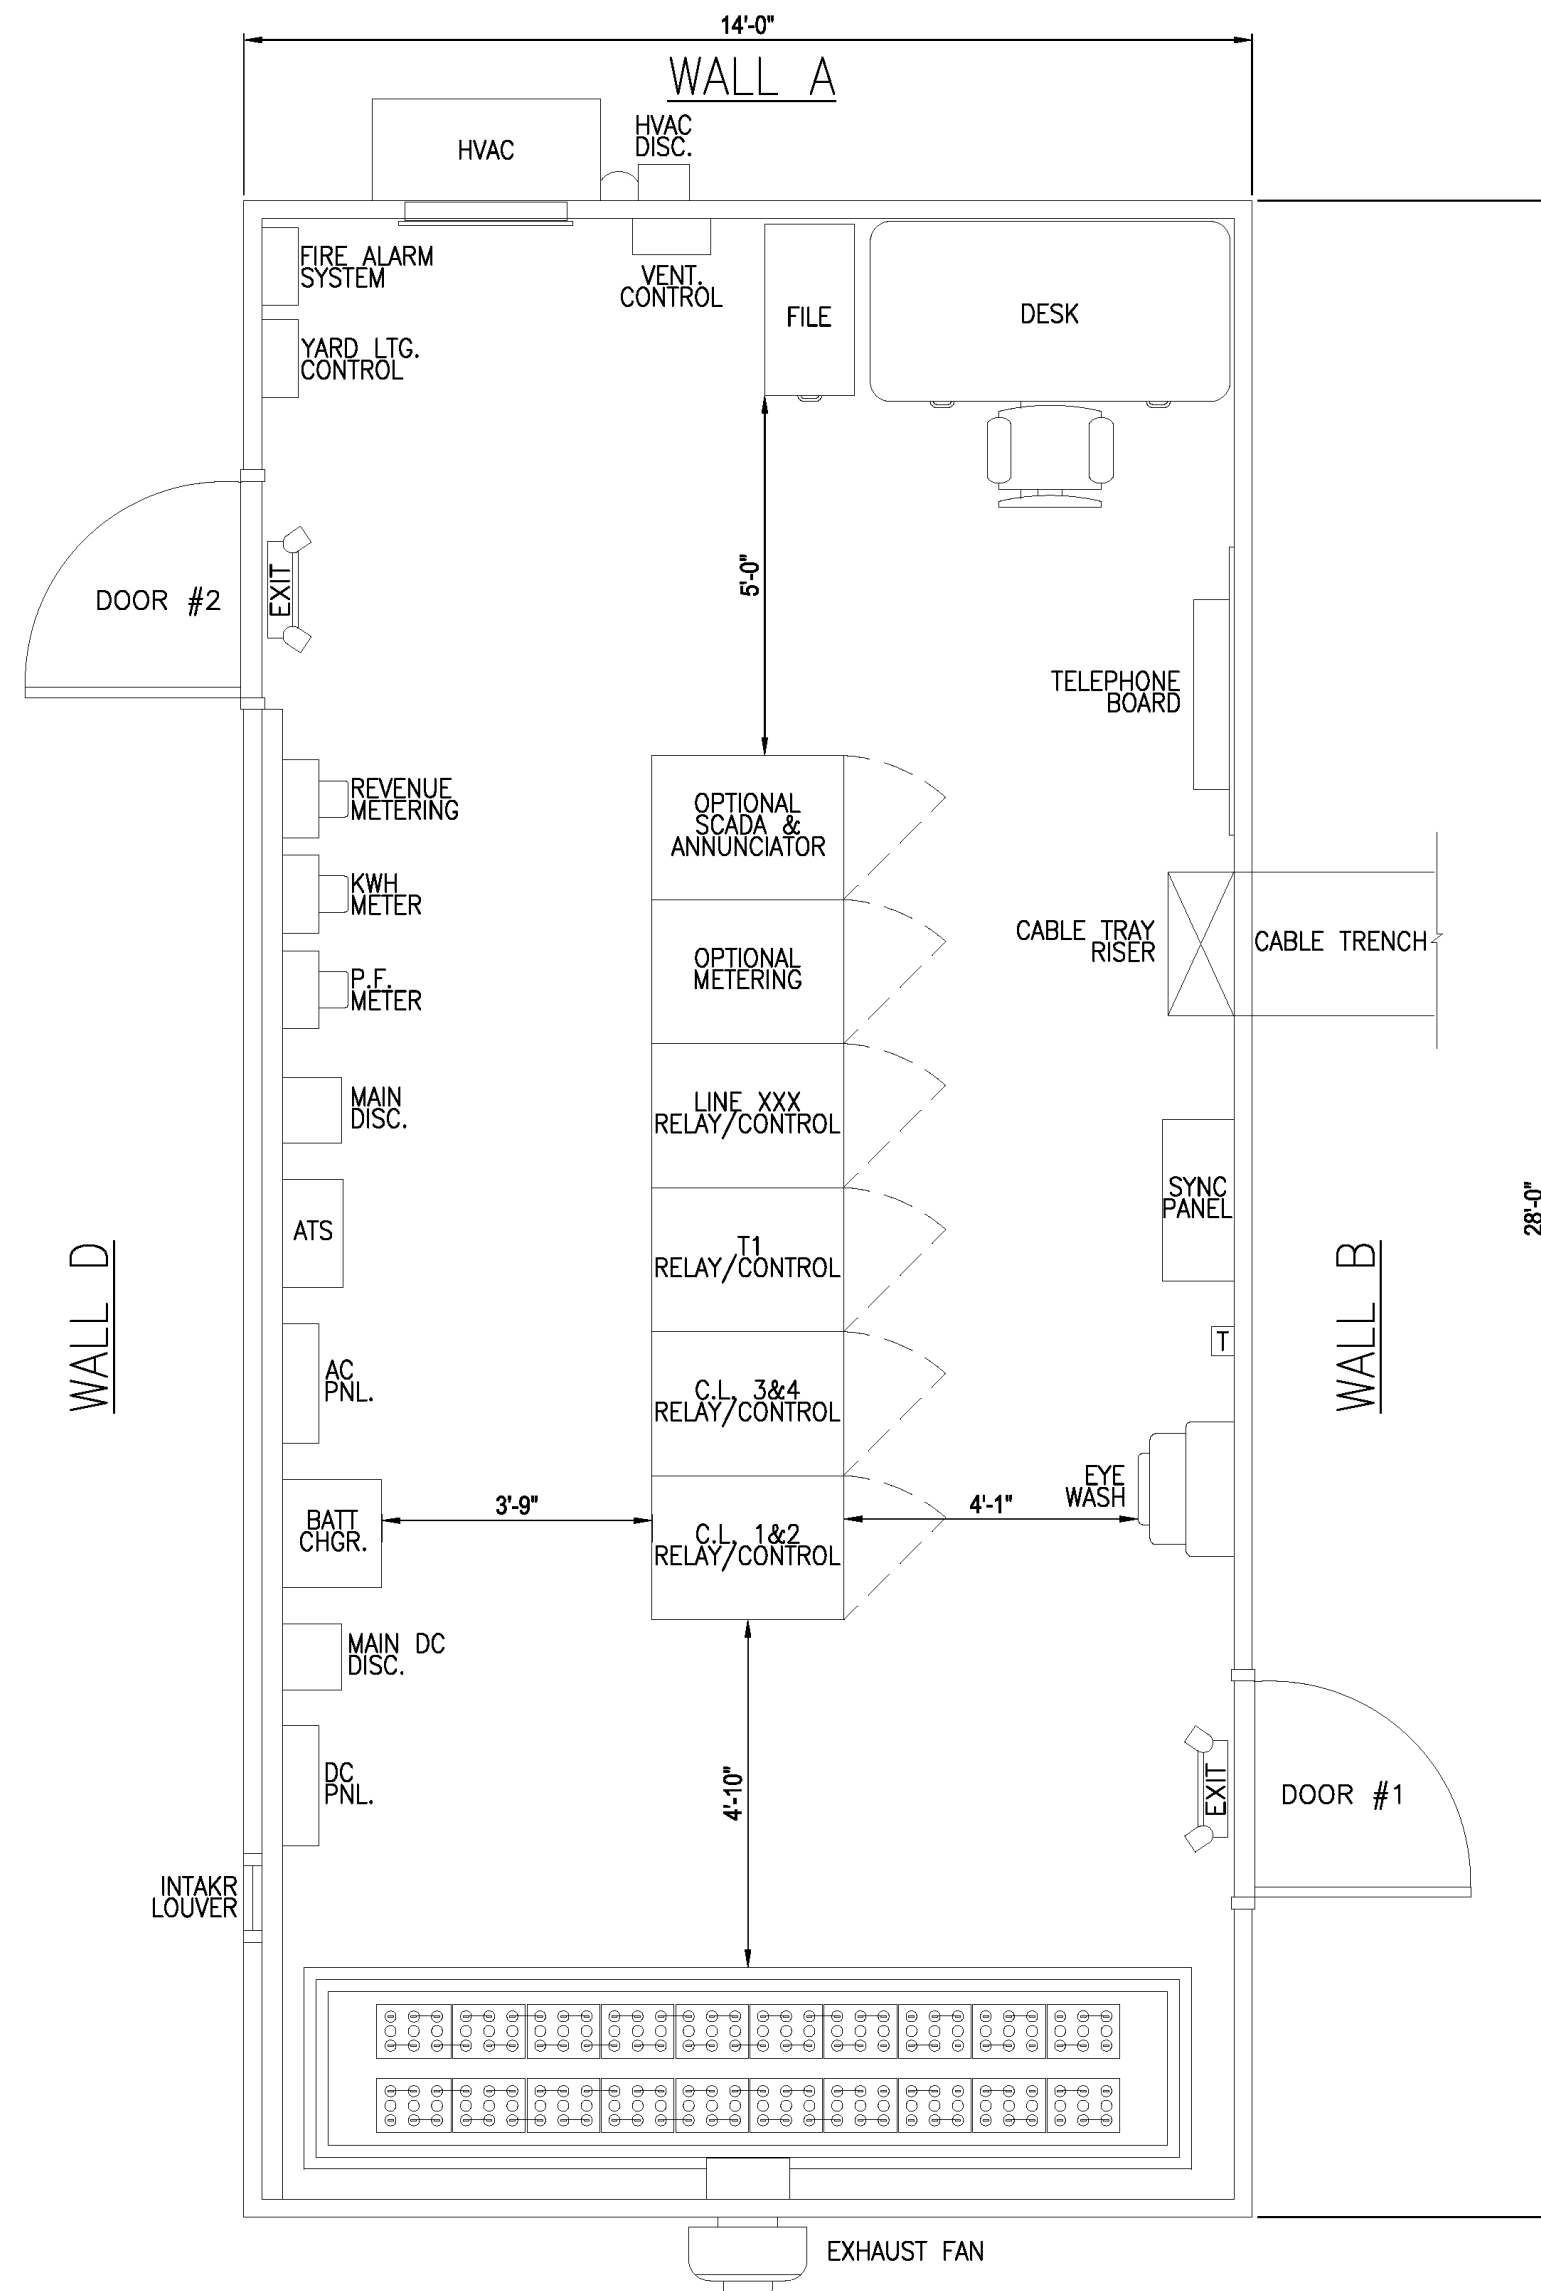

WALL C
CONTROL ROOM FLOOR PLAN

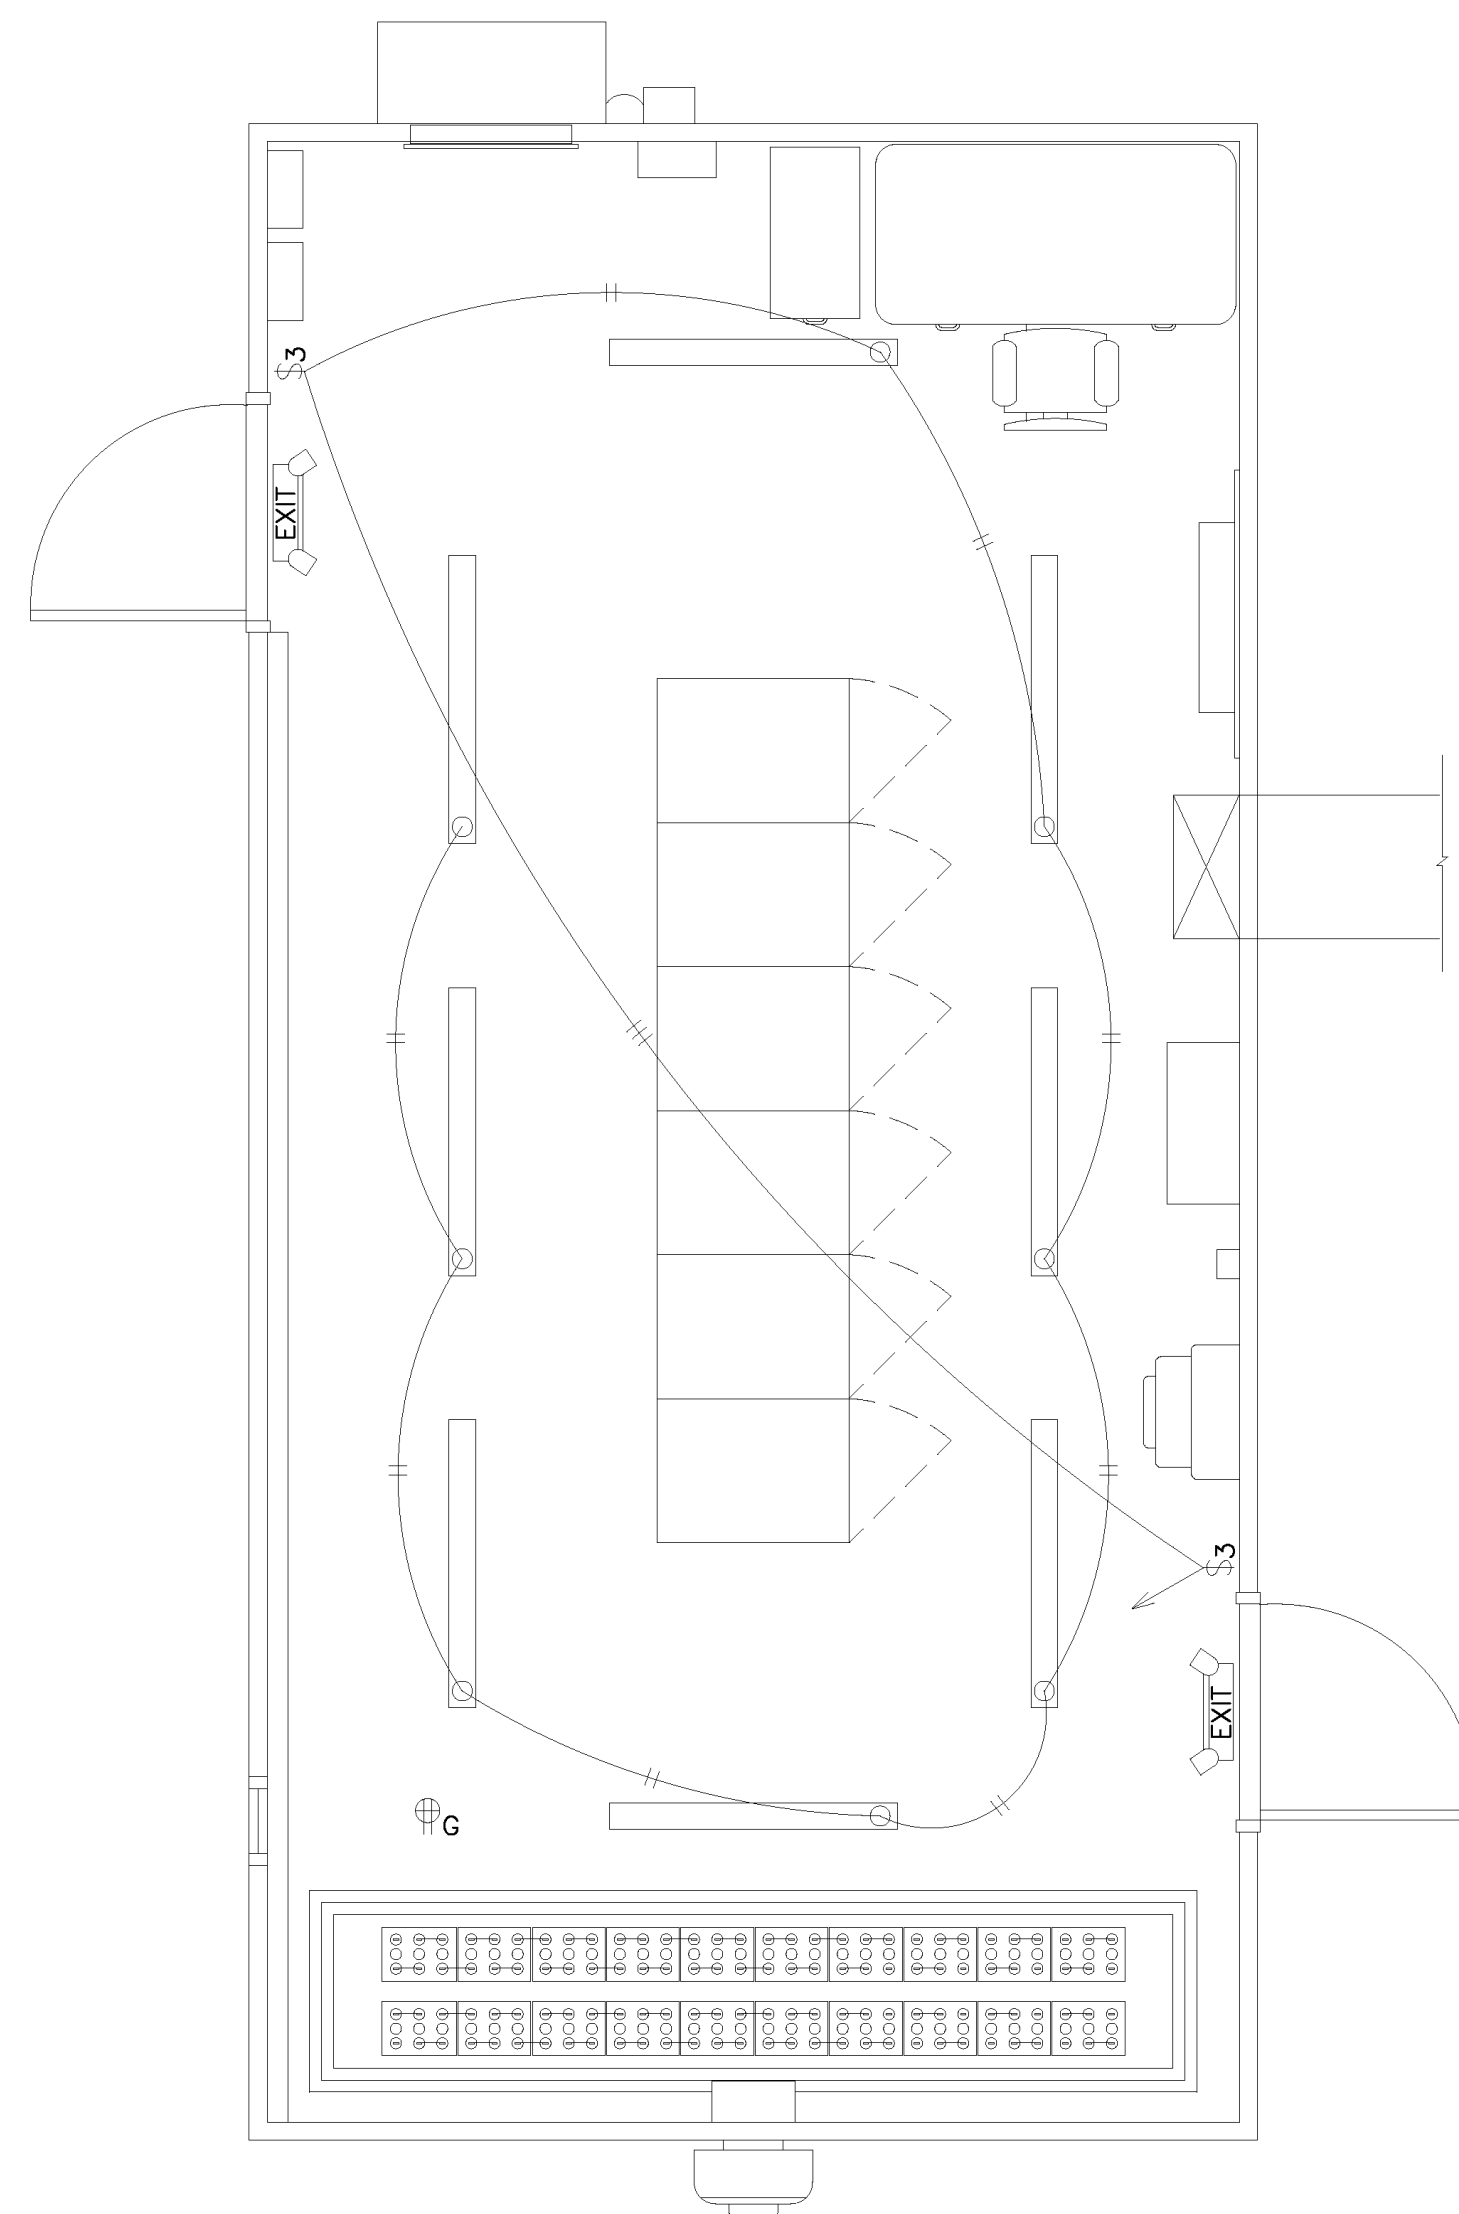


CONTROL ROOM LIGHTING PLAN

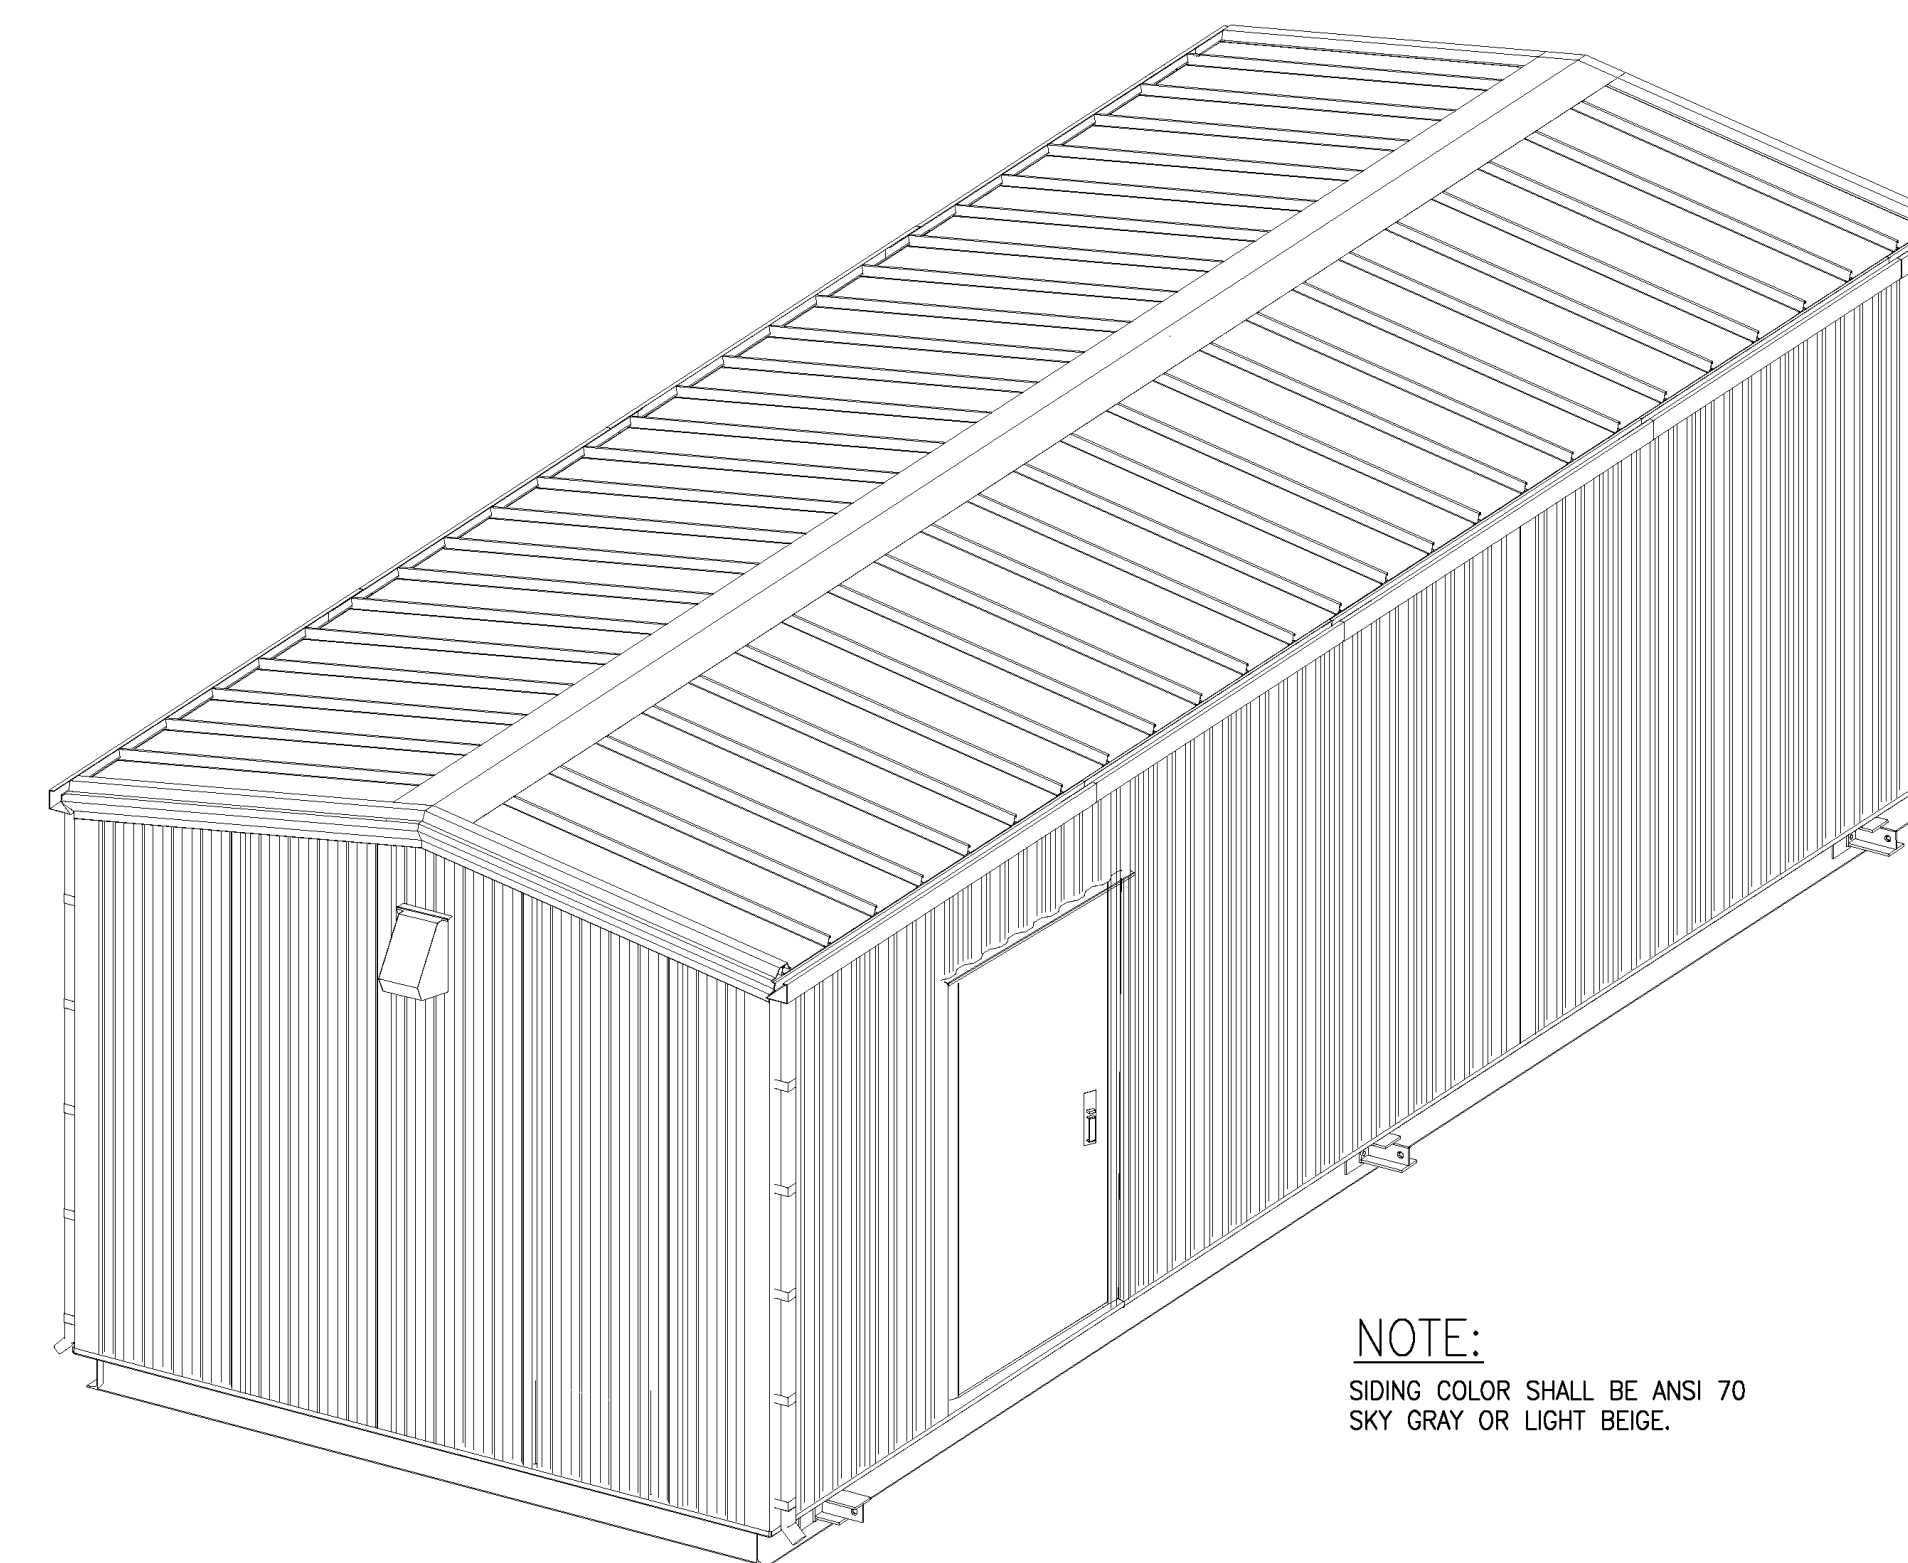


3D VIEW

NOTE:
SIDING COLOR SHALL BE ANSI 70
SKY GRAY OR LIGHT BEIGE.

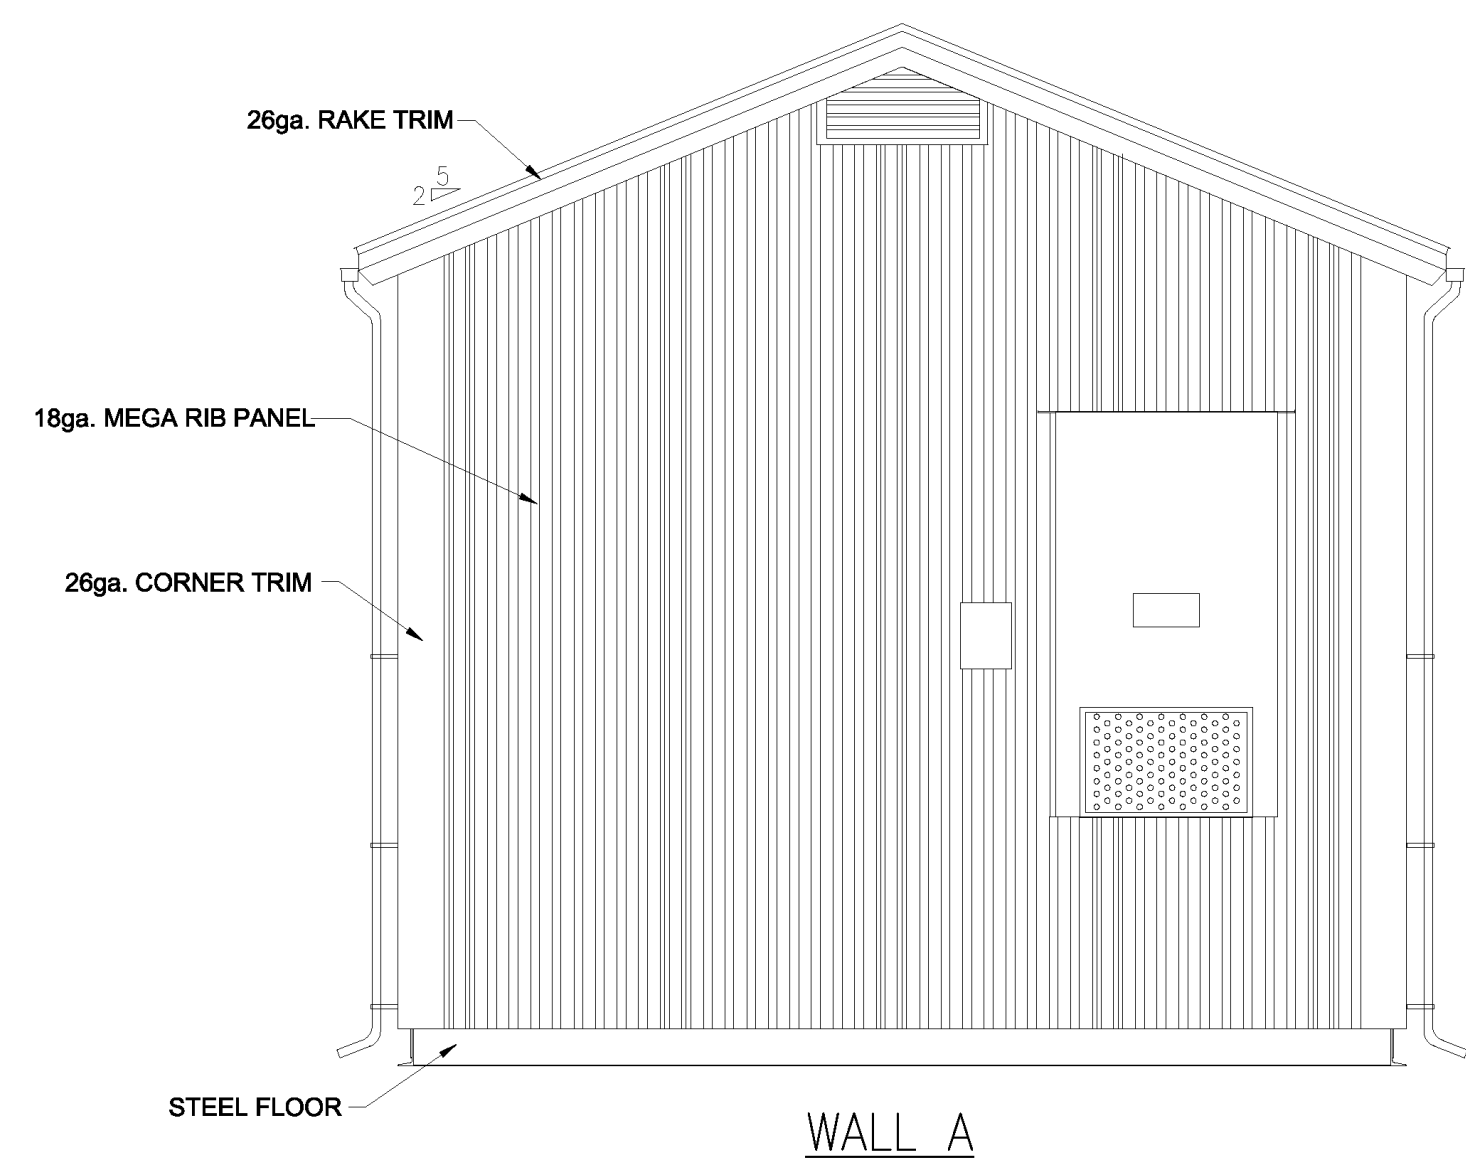

WALL A

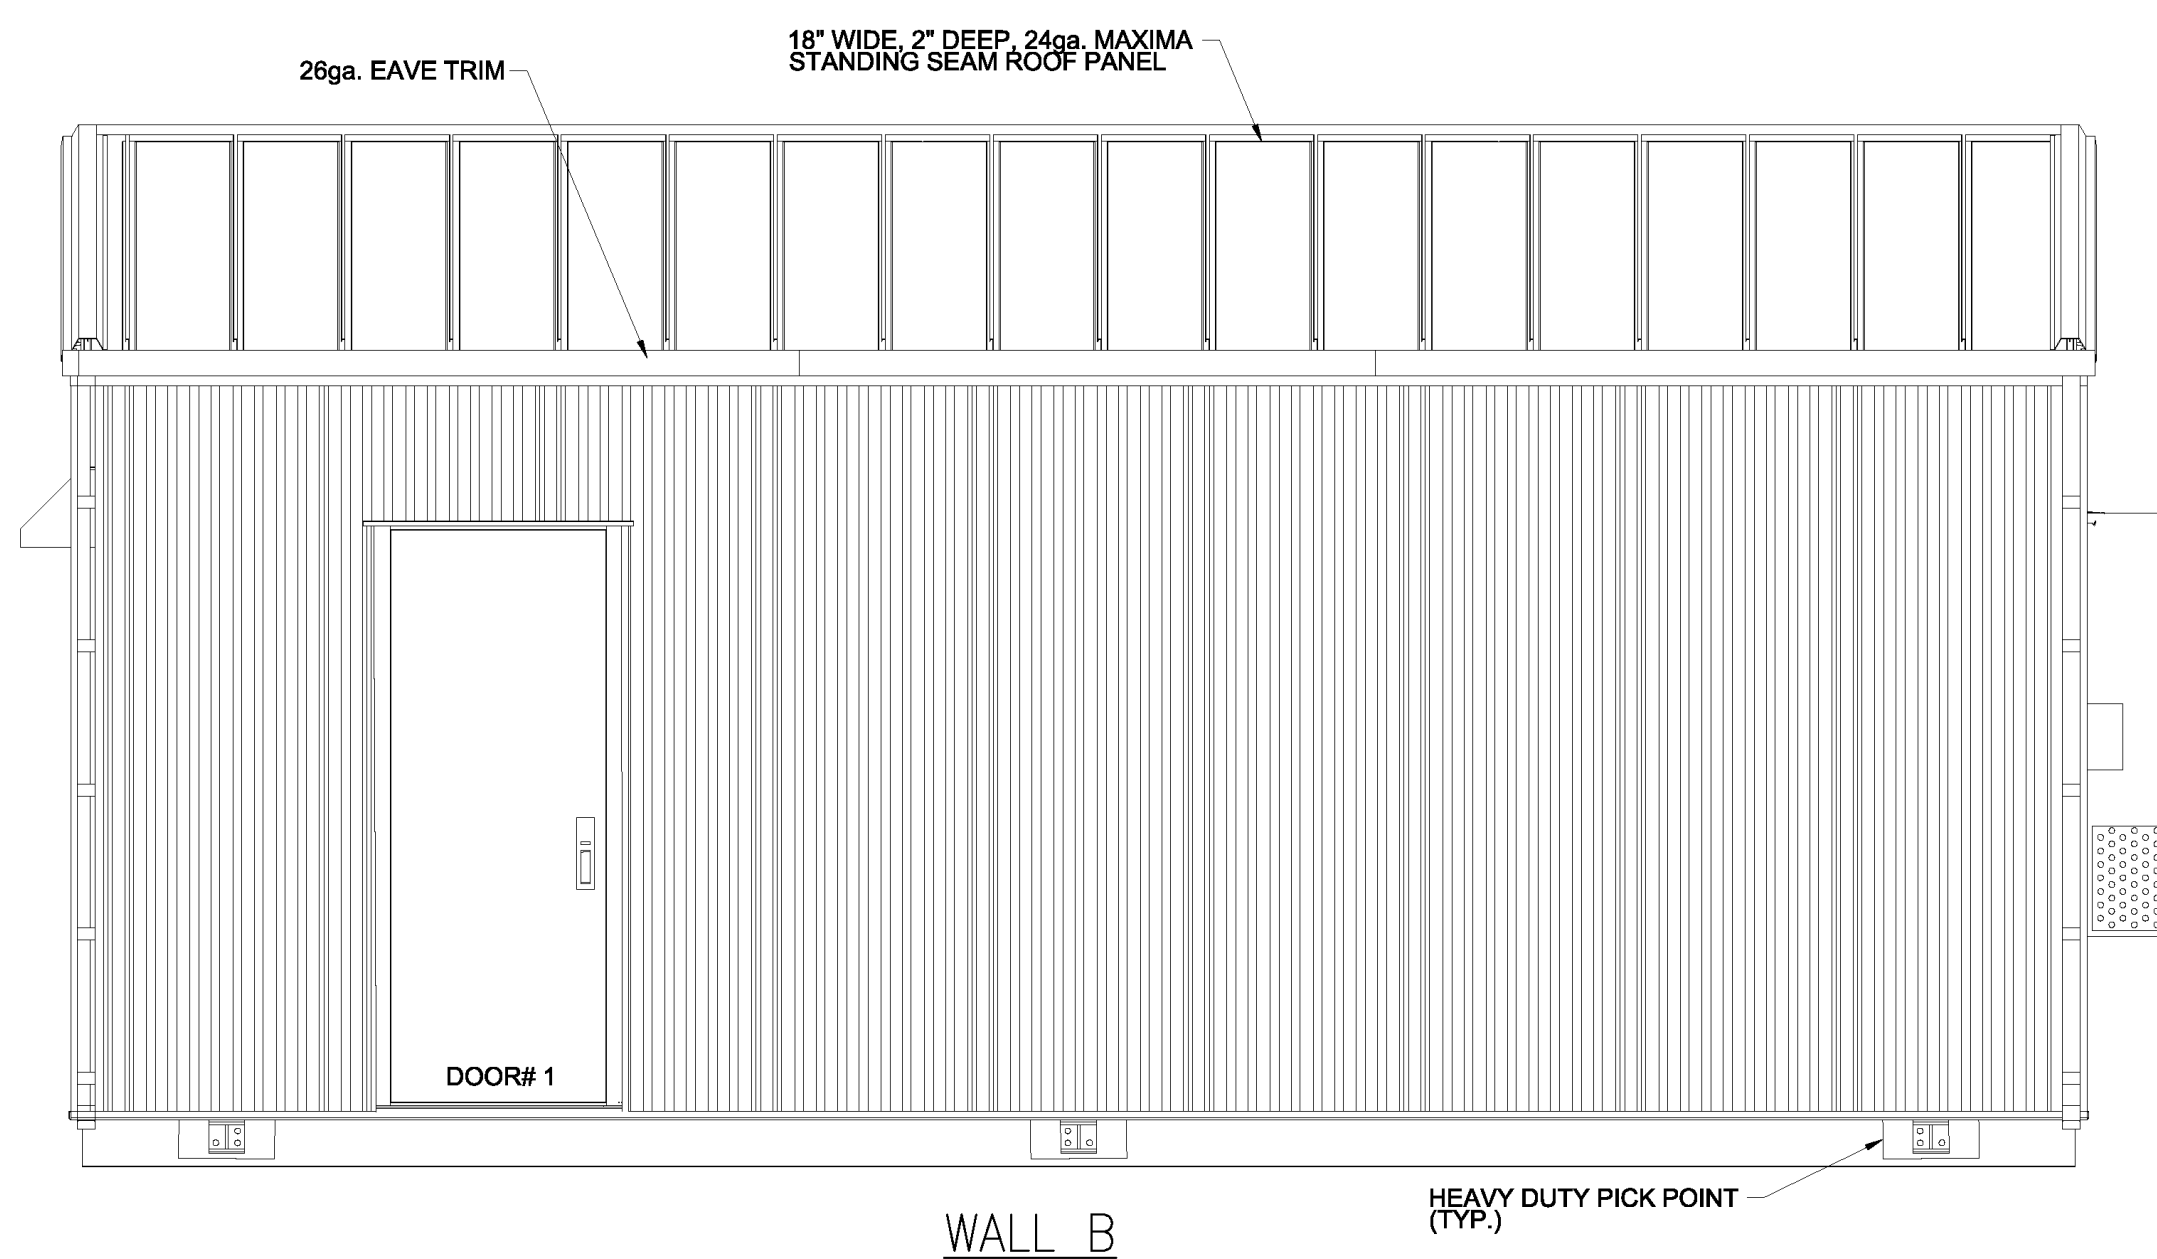

WALL B

REFERENCE DRAWINGS:

- S-001 - COLLECTOR SUBSTATION POWER ONE LINE DIAGRAM
- S-002 - COLLECTOR SUBSTATION GENERAL ARRANGEMENT PLAN
- S-003 - COLLECTOR SUBSTATION ELEVATIONS & SECTIONS A-A, B-B
- S-004 - COLLECTOR SUBSTATION SECTIONS C-C, D-D
- S-005 - COLLECTOR SUBSTATION YARD LIGHTING PLAN
- S-006 - COLLECTOR SUBSTATION FENCE & GROUNDING PLAN
- S-007 - COLLECTOR SUBSTATION FENCE & GROUNDING DETAILS

PRELIMINARY
NOT FOR CONSTRUCTION

LEGEND:

- Ⓢ - SINGLE TOGGLE SWITCH
- Ⓢ3 - 3 WAY TOGGLE SWITCH
- ⓈT - HVAC THERMOSTAT
- - WIRING HOME RUN, SINGLE POLE
- - WIRING HOME RUN, DOUBLE POLE
- ⓈG - DOUBLE DUPLEX OUTLET, 20A

LIGHTING SCHEDULE:

- - FLOURESCENT LIGHT FIXTURE, 2 LAMP 4', 32 WATT, 120V
- - OUTDOOR LIGHT FIXTURE, HIGH PRESSURE SODIUM, 70 WATT, 120V
- EXIT - EMERGENCY BATTERY LIGHT/EXIT SIGN, 120V



PROJECT NO: 327851

REV	DESCRIPTION	DATE	DES	CHK	APP
A	ISSUED FOR CLIENT REVIEW	06/20/19	AAD	DG	AKD

AAD/TRC
DESIGNED
AAD/TRC
DRAWN
DG/TRC
CHECKED
AKD/TRC
APPROVED

PRELIMINARY
COLLECTOR SUBSTATION CONTROL HOUSE ELECTRICAL LAYOUT PLAN
EAST POINT ENERGY CENTER
EAST POINT ENERGY CENTER, LLC
SHARON
SCHOHARIE CO., NY


REVIEW 1
REVIEW 2

06/20/19
DATE
3/8"=1'-0"
SCALE




S-008


REV.
A

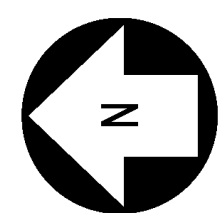


ADJUST DIRECTION OF NORTH ARROW AS NEEDED

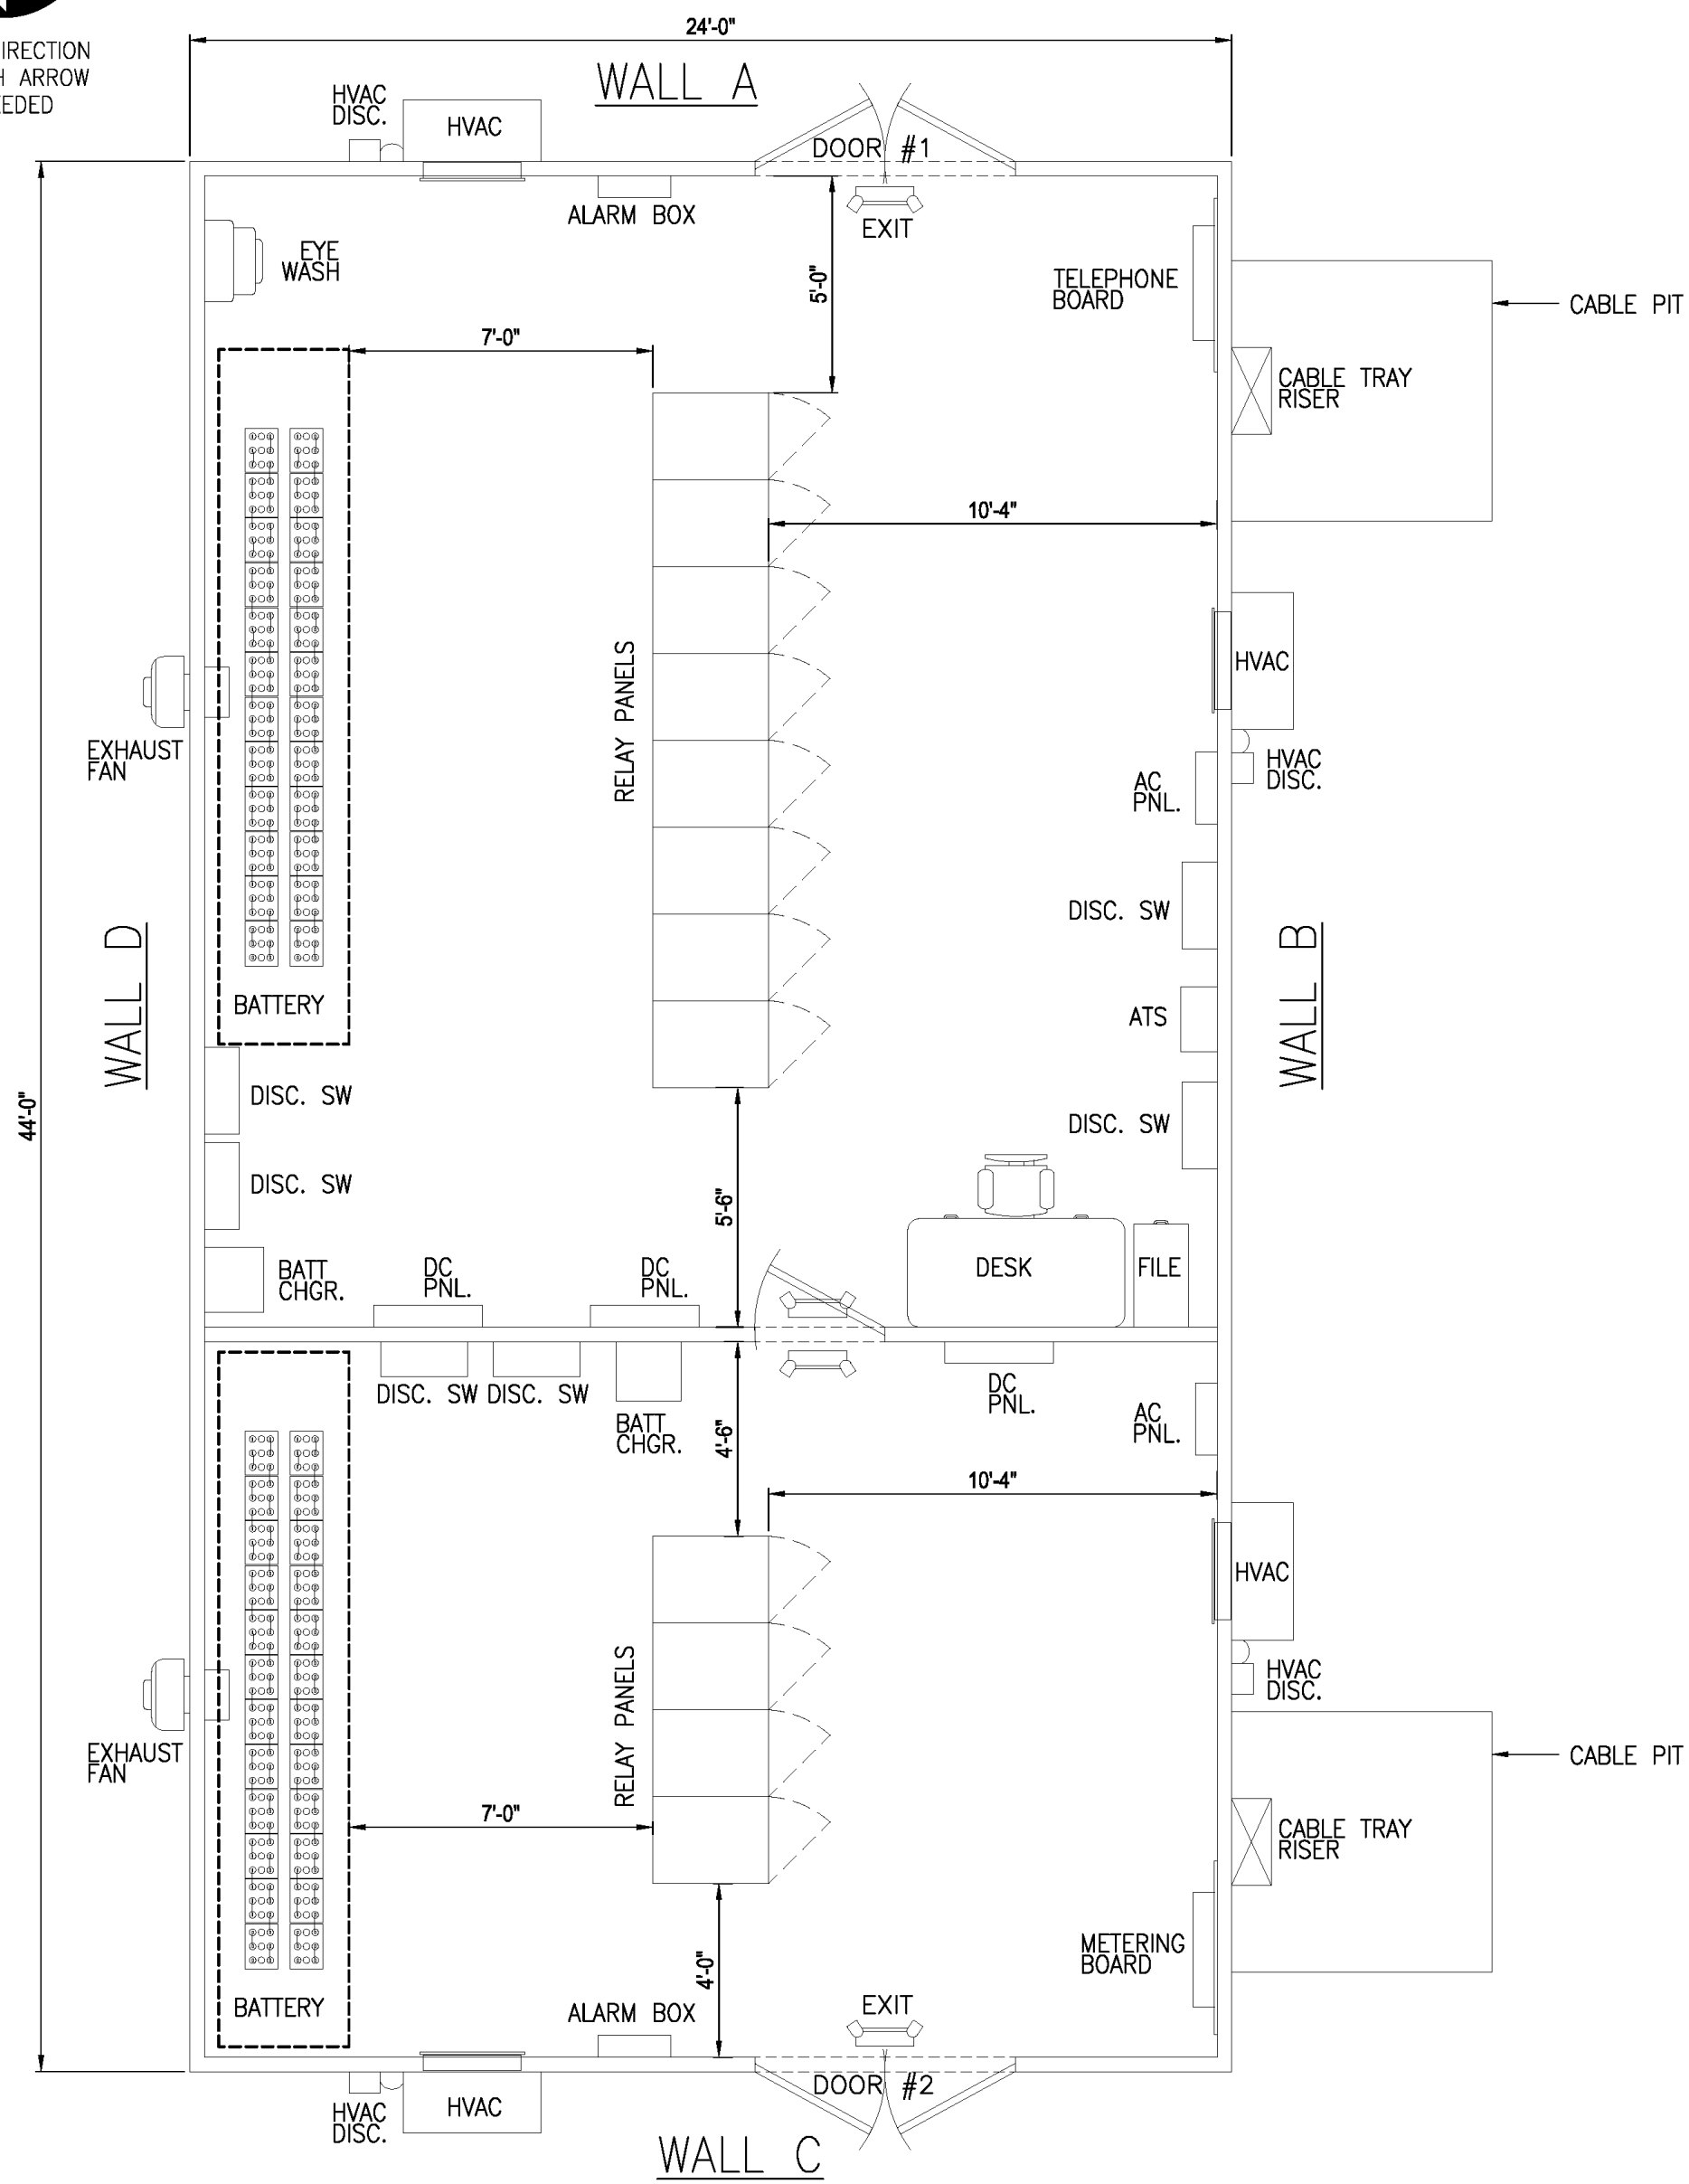

CONTROL ROOM FLOOR PLAN

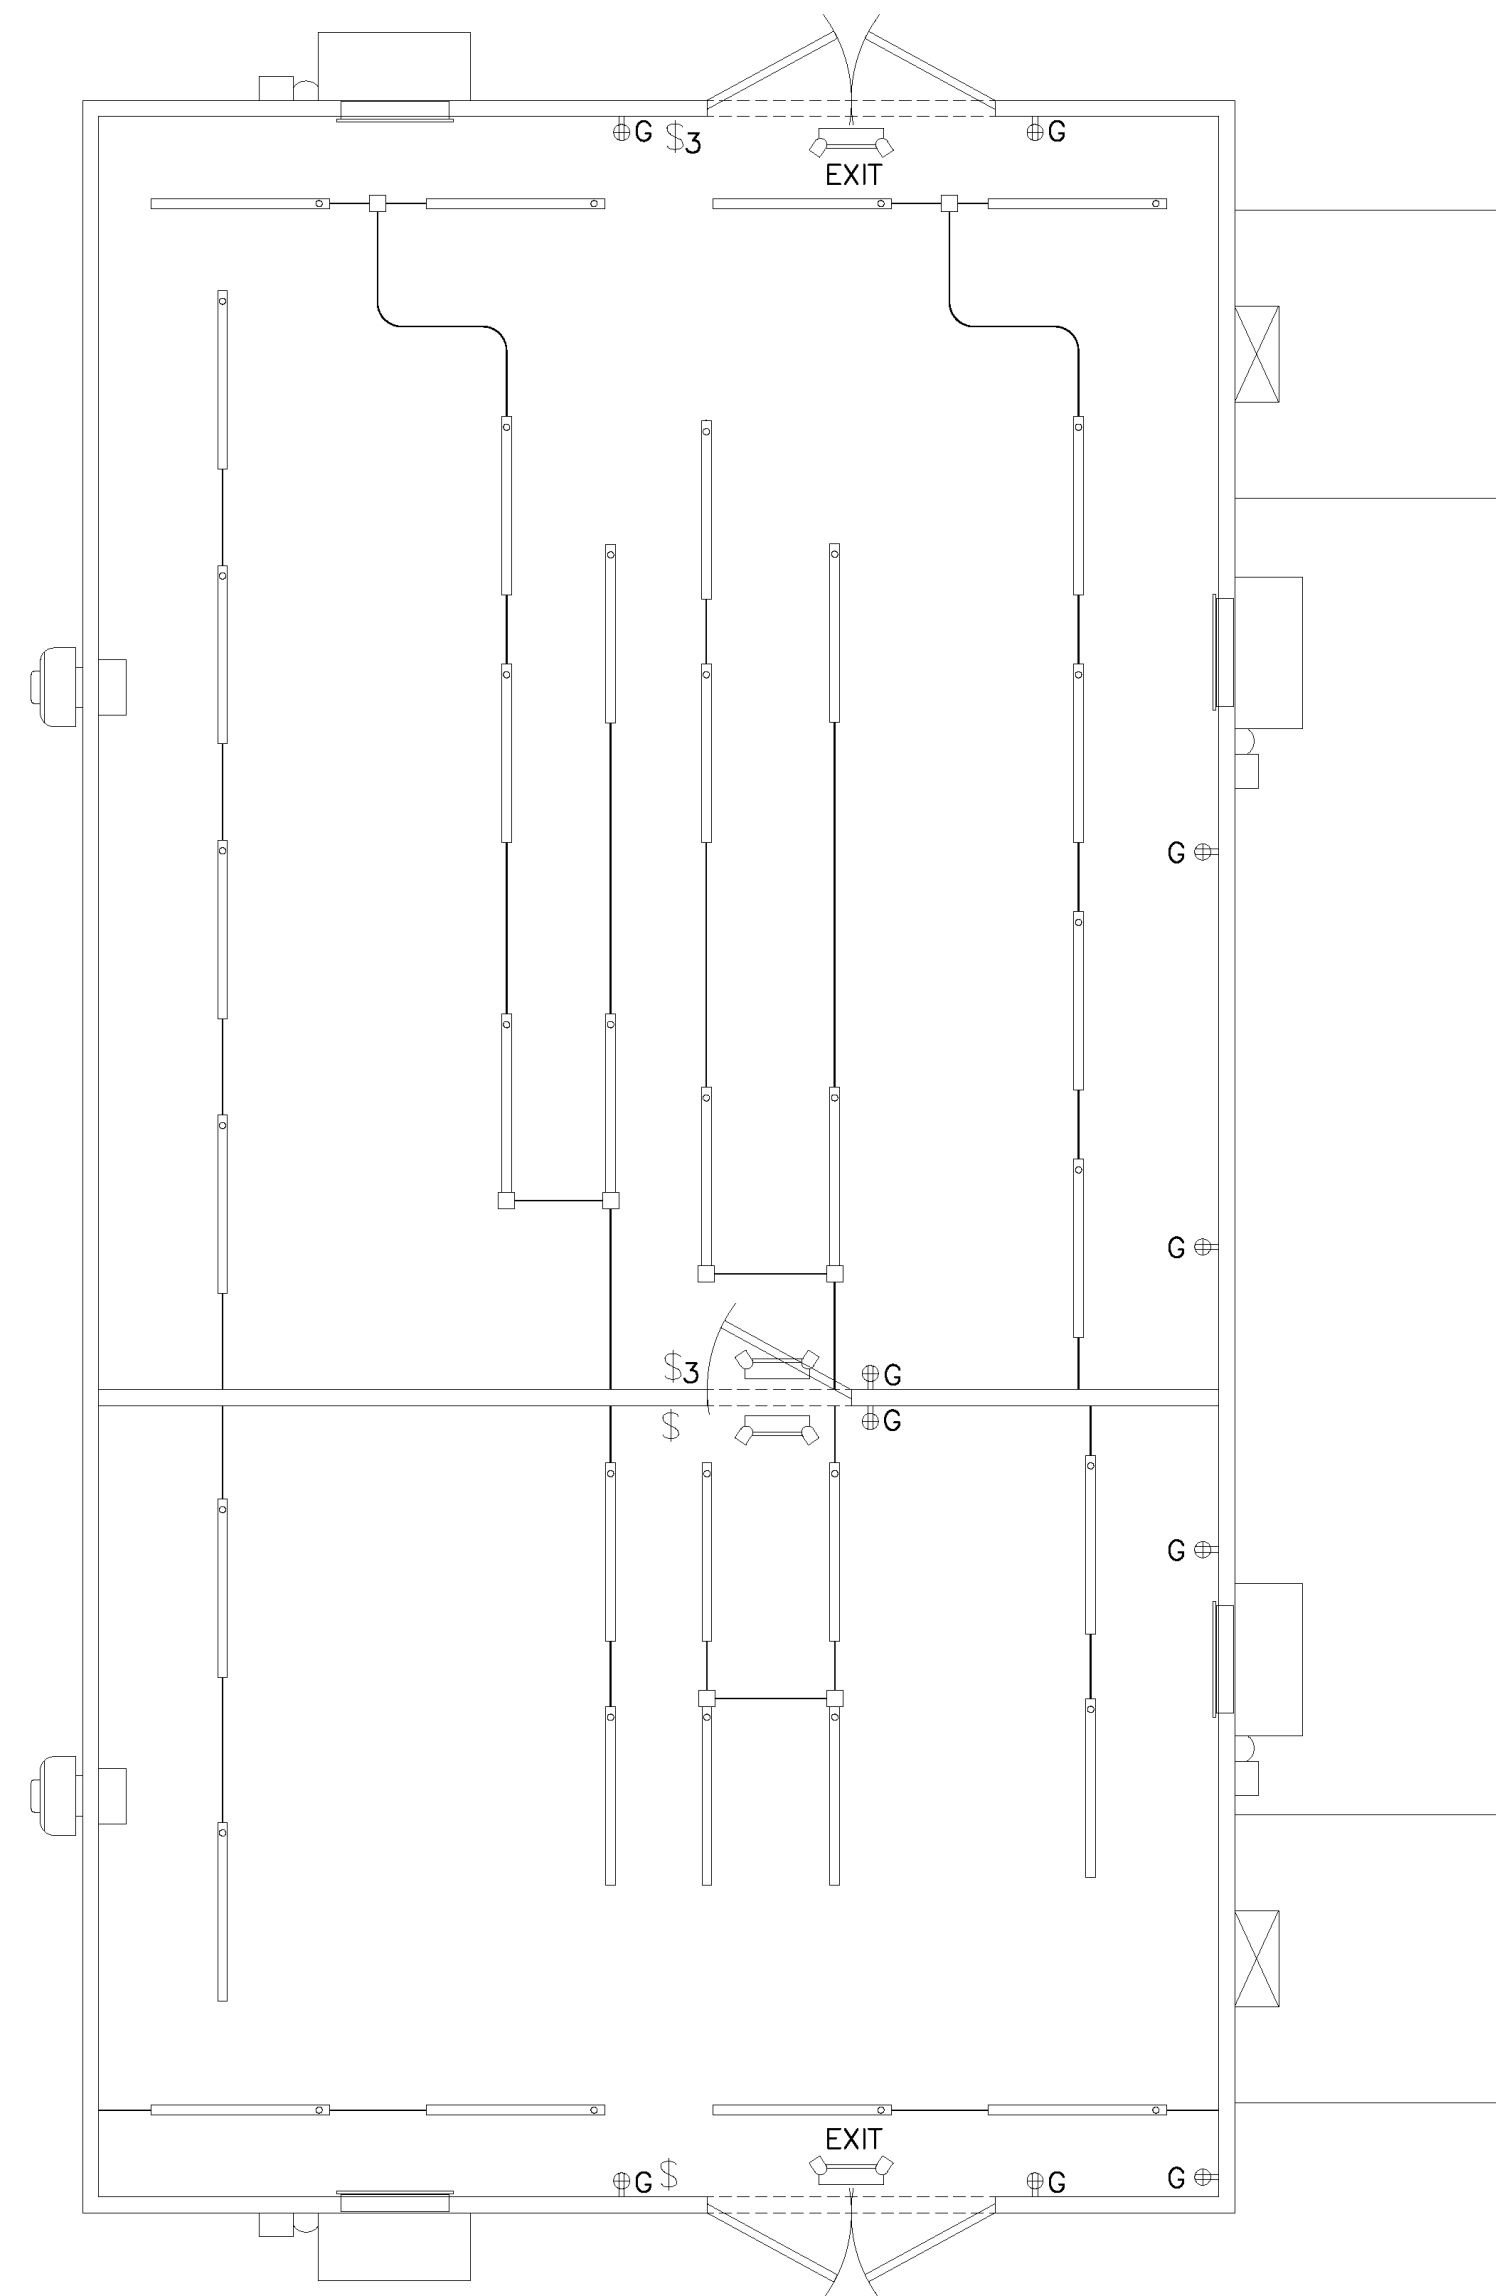


CONTROL ROOM LIGHTING PLAN

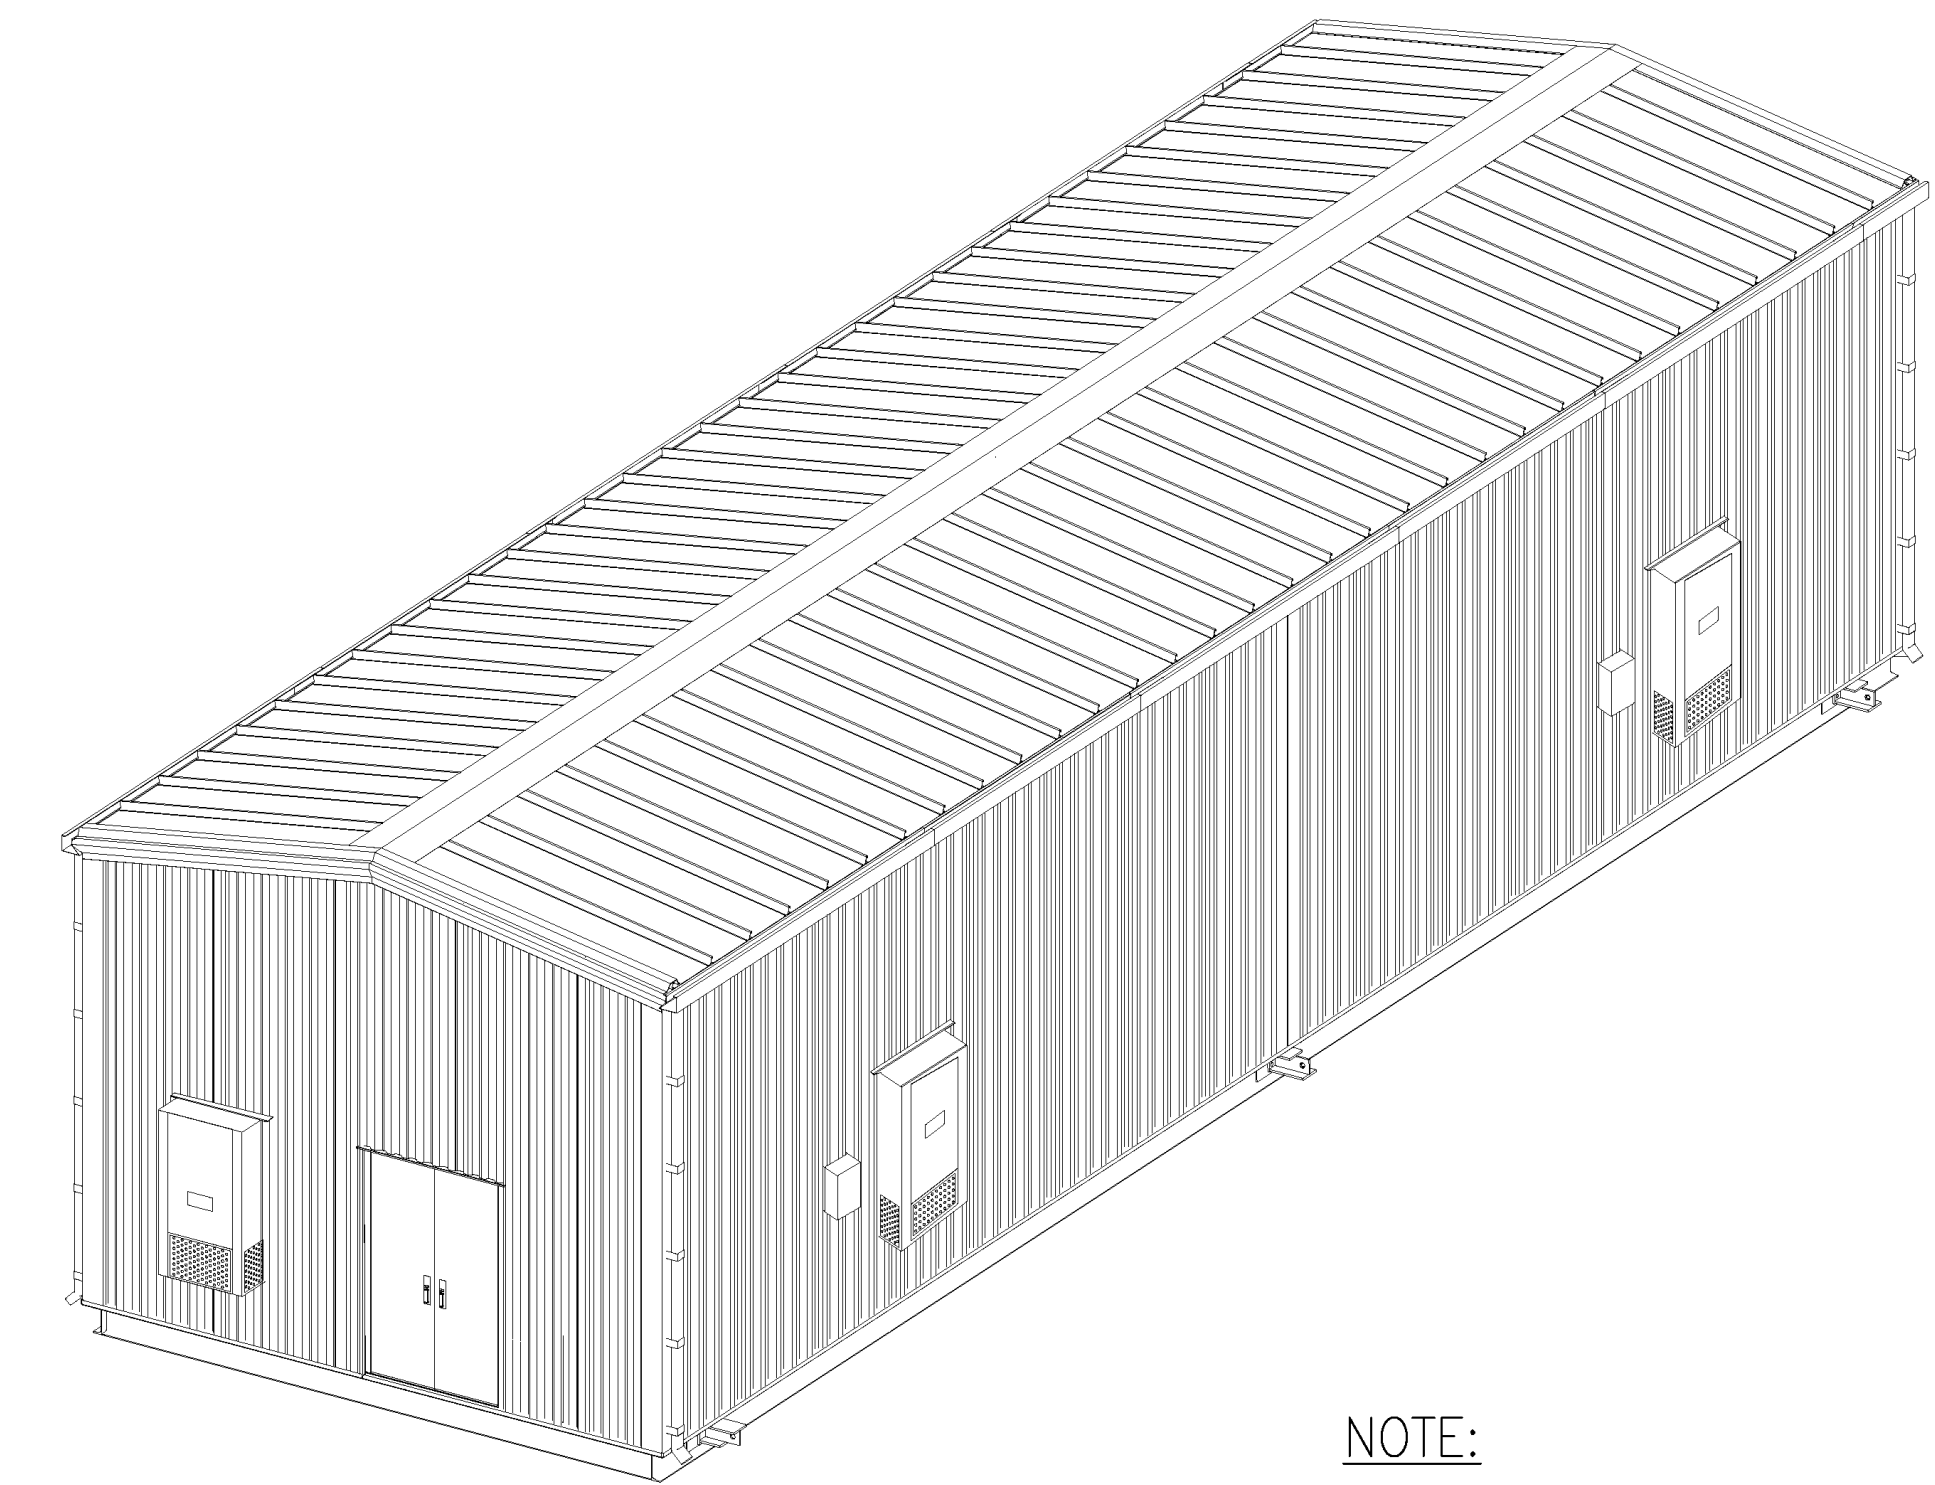


3D VIEW

NOTE:
SIDING COLOR SHALL BE ANSI 70 SKY GRAY OR LIGHT BEIGE.

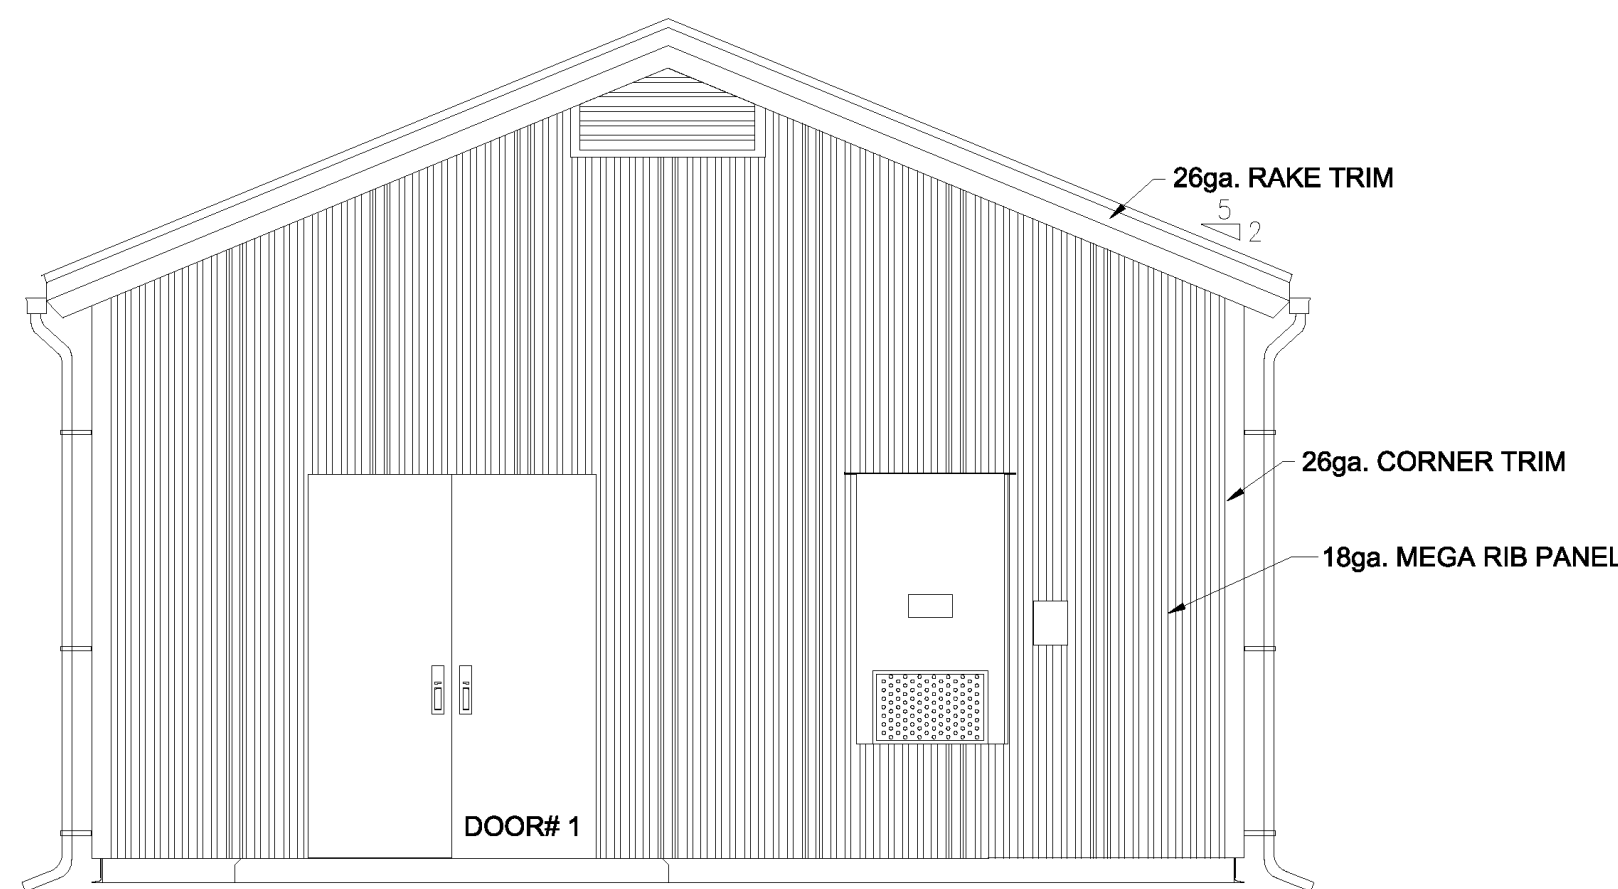

WALL A

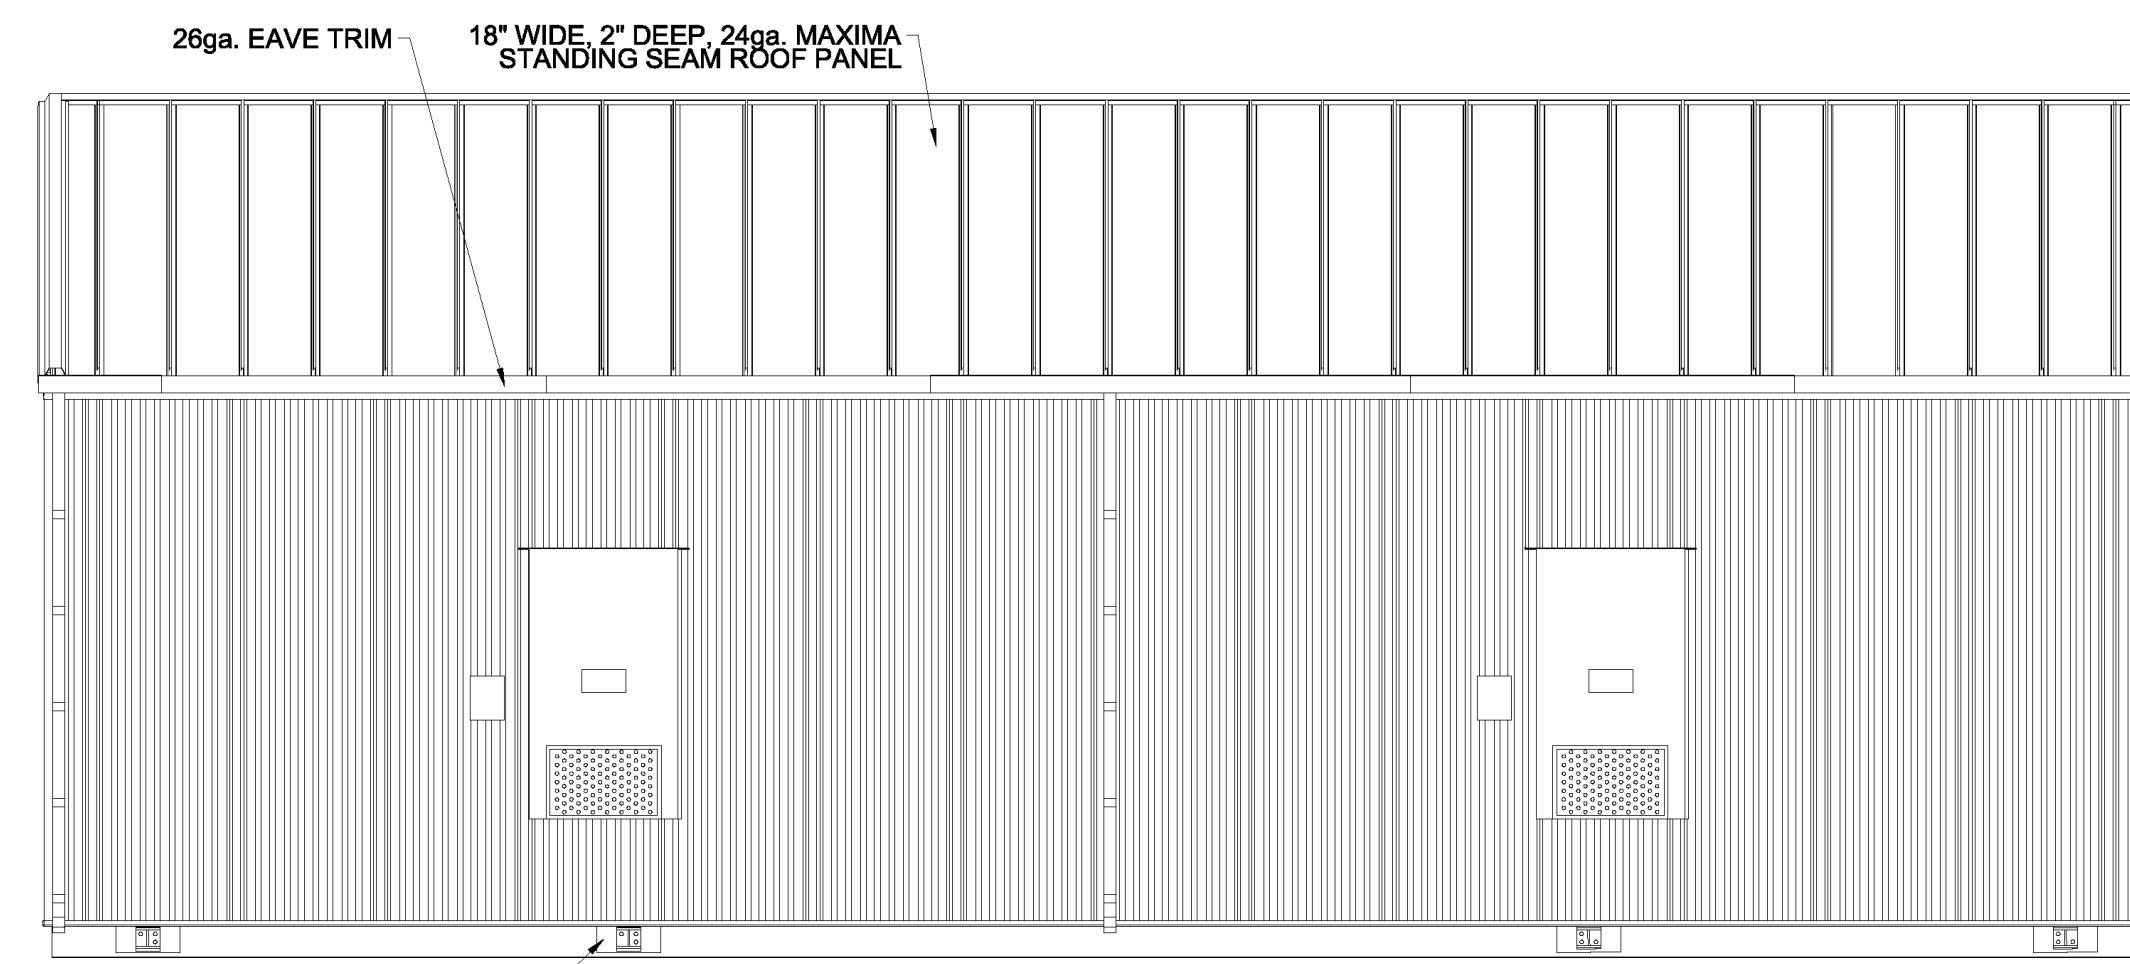

WALL B

REFERENCE DRAWINGS:

- S-009 - SWITCHYARD SUBSTATION POWER ONE-LINE DIAGRAM
- S-010 - SWITCHYARD SUBSTATION GENERAL ARRANGEMENT PLAN
- S-011 - SWITCHYARD SUBSTATION SECTIONS A-A, B-B
- S-012 - SWITCHYARD SUBSTATION SECTIONS C-C, D-D, E-E
- S-013 - SWITCHYARD SUBSTATION YARD LIGHTING PLAN
- S-014 - SWITCHYARD SUBSTATION FENCE & GROUNDING PLAN
- S-015 - SWITCHYARD SUBSTATION FENCE & GROUNDING DETAILS

PRELIMINARY
NOT FOR CONSTRUCTION

LEGEND:

- ⊞ - SINGLE TOGGLE SWITCH
- ⊞3 - 3 WAY TOGGLE SWITCH
- T - HVAC THERMOSTAT
- - WIRING HOME RUN, SINGLE POLE
- - WIRING HOME RUN, DOUBLE POLE
- ⊞G - DOUBLE DUPLEX OUTLET, 20A

LIGHTING SCHEDULE:

- ⊞ - FLOURESCENT LIGHT FIXTURE, 2 LAMP 4', 32 WATT, 120V
- ⊞ - OUTDOOR LIGHT FIXTURE, HIGH PRESSURE SODIUM, 70 WATT, 120V
- EXIT - EMERGENCY BATTERY LIGHT/EXIT SIGN, 120V



PROJECT NO: 327851

REV	DESCRIPTION	DATE	DES	CHK	APP
A	ISSUED FOR CLIENT REVIEW	06/20/19	AAD	DG	AKD

AAD/TRC DESIGNED AAD/TRC DRAWN DG/TRC CHECKED AKD/TRC APPROVED	PRELIMINARY SWITCHYARD SUBSTATION CONTROL HOUSE ELECTRICAL LAYOUT PLAN EAST POINT ENERGY CENTER EAST POINT ENERGY CENTER, LLC SCHOHARIE CO., NY		REV. A S-016
REVIEW 1 REVIEW 2	DATE 06/20/19 SCALE 1/4"=1'-0"		